



THIS DRAWING PREPARED AT THE
VIRGINIA BEACH OFFICE
 2901 South Lynnhaven Road, Suite 201 | Virginia Beach, VA 23452
 TEL: 757-215-8679 FAX: 757-346-1415 www.timmons.com

YOUR VISION ACHIEVED THROUGH OURS.



DATE	REVISION DESCRIPTION
3/2023	FILE UPDATE: PIPE SUPPORTS
1/26/2023	
	DRAWN BY L. KIM
	DESIGNED BY K. TURNER
	CHECKED BY K. TURNER
	SCALE 3/8"=1'-0"

TIMMONS GROUP

OLD STAGE ROAD BOOSTER PUMP STATION
 ISLE OF WIGHT COUNTY - VIRGINIA
 BPS MECHANICAL PIPING PLAN AND SECTIONS

JOB NO.	48527
SHEET NO.	M1



These plans and associated documents are the exclusive property of TIMMONS GROUP and may not be reproduced in whole or in part and shall not be used for any purpose whatsoever, inclusive, but not limited to construction, bidding, and/or construction staking without the express written consent of TIMMONS GROUP.

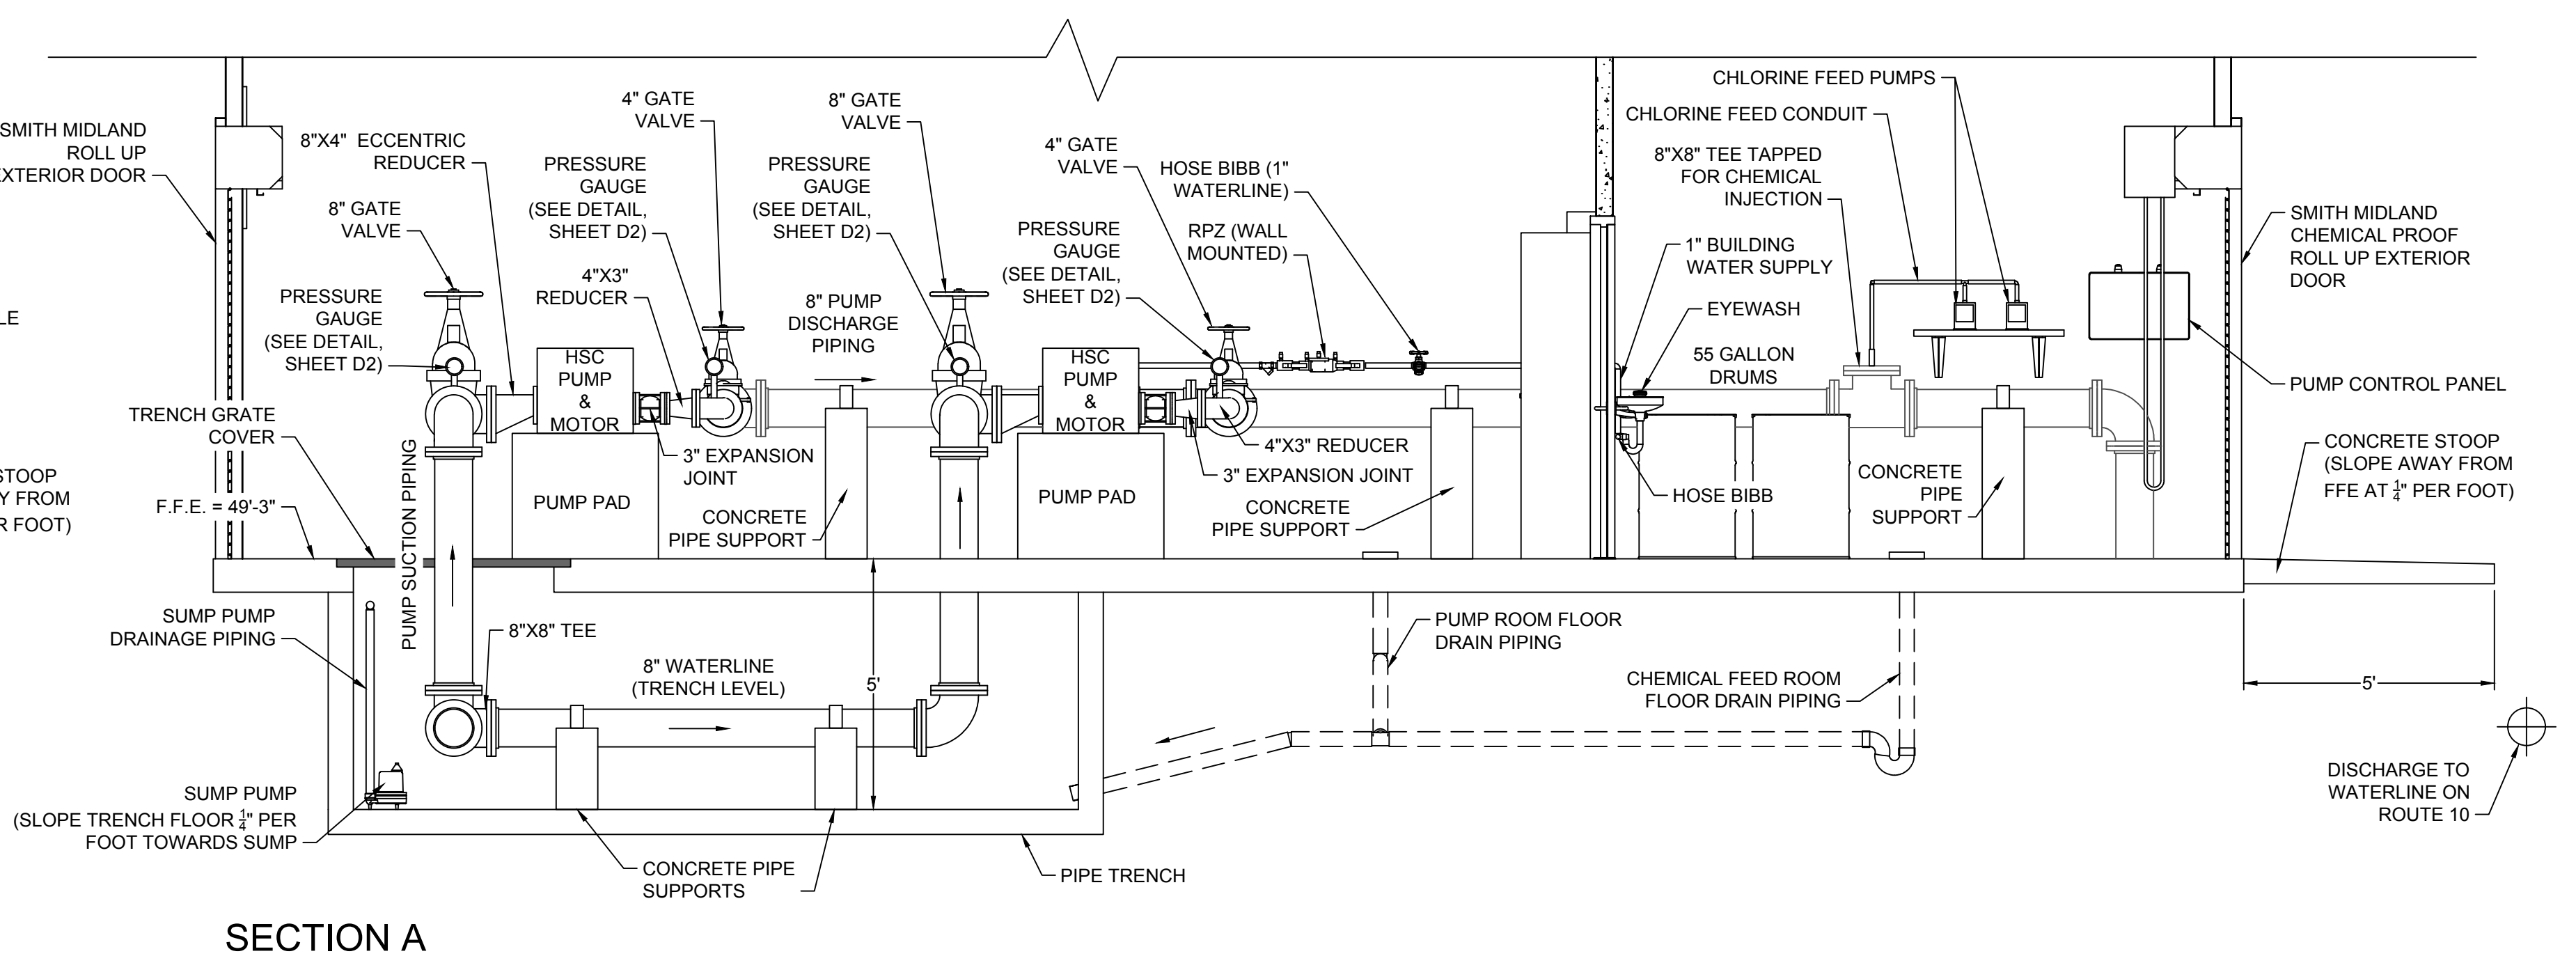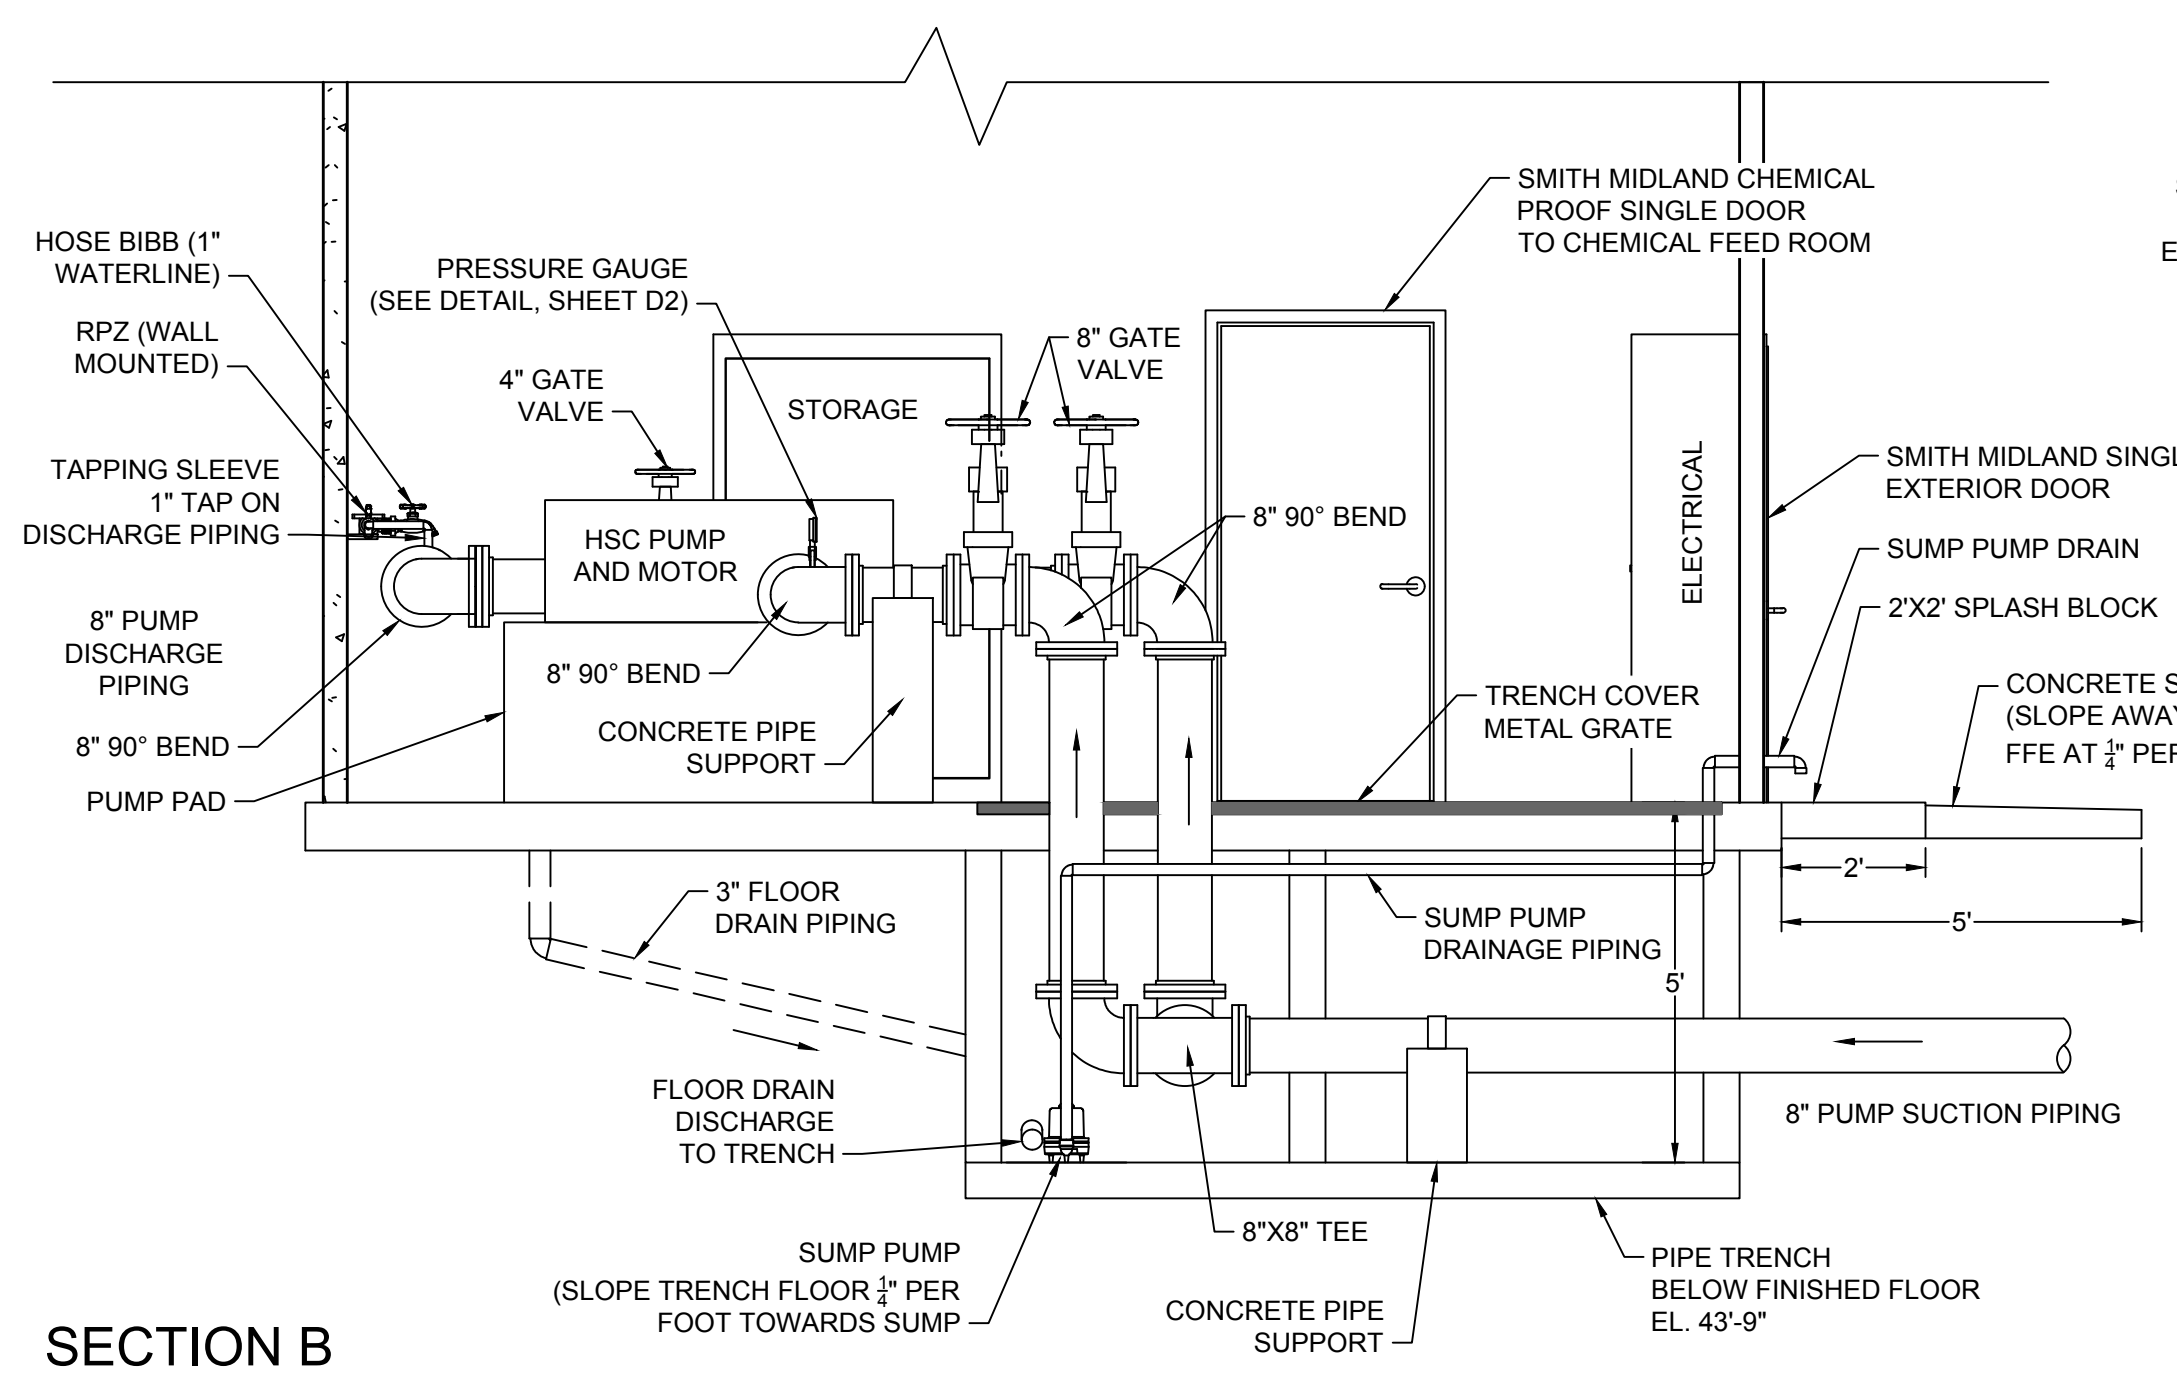

SECTION B


SECTION A

NOTE:
 1. NOT ALL MEP COMPONENTS ARE SHOWN ON THIS SHEET. REFER TO DESIGN, NOTES, AND DETAILS ON SHEETS E1-E5 AND SHEETS P1-P4, THIS PLAN SET, FOR COMPLETE MEP DESIGN.

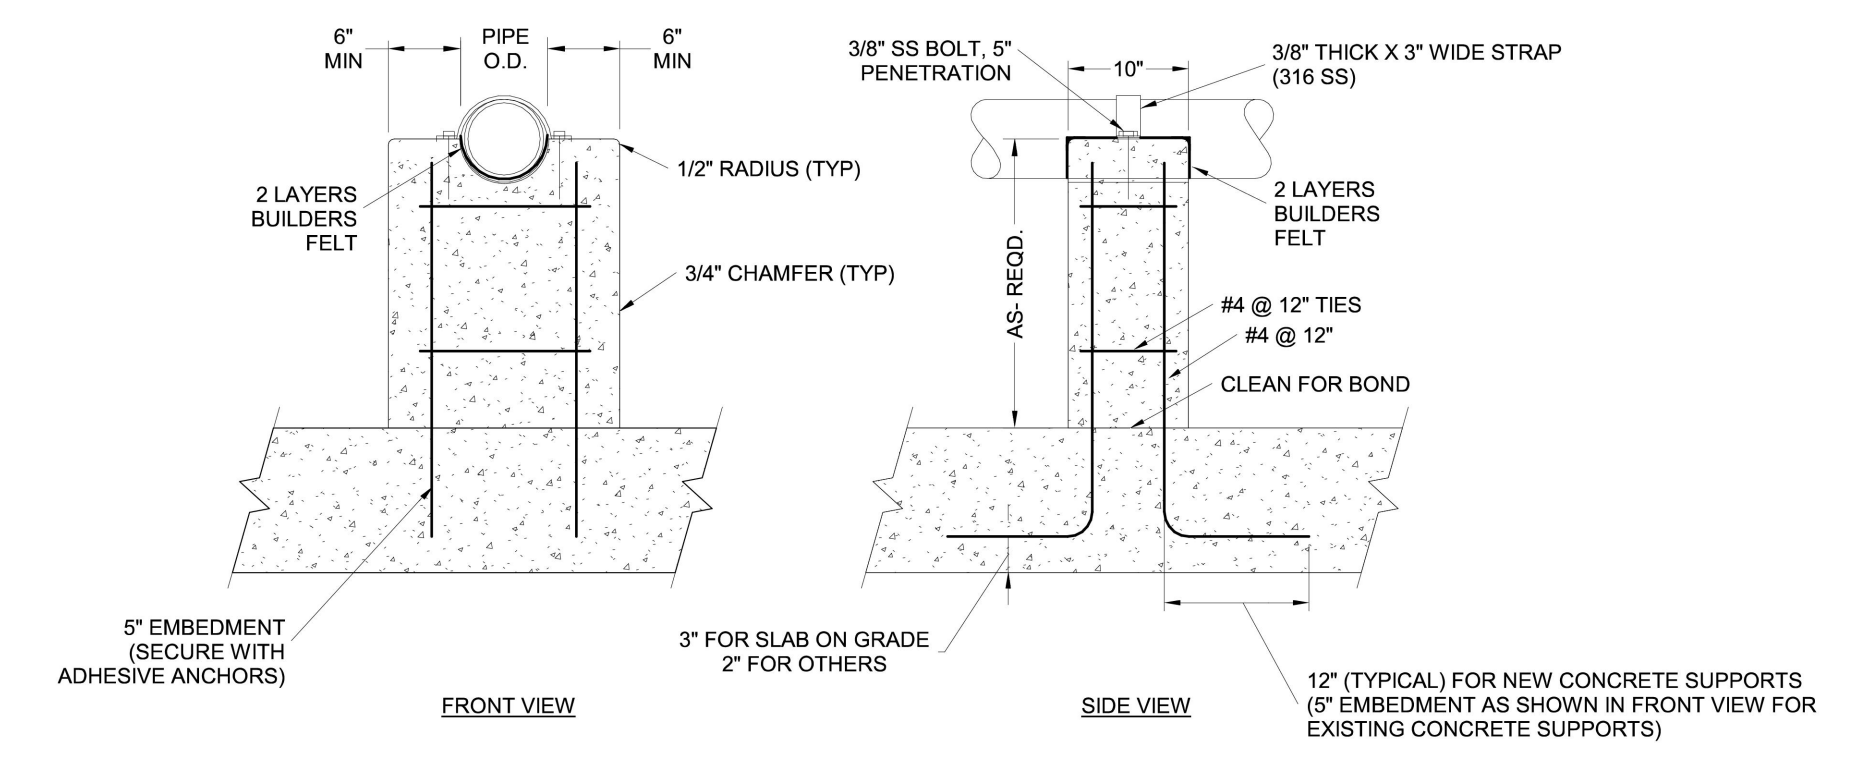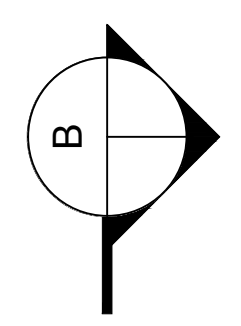

CONCRETE PIPE SUPPORT DETAIL

NOT TO SCALE
 (10 REQUIRED)

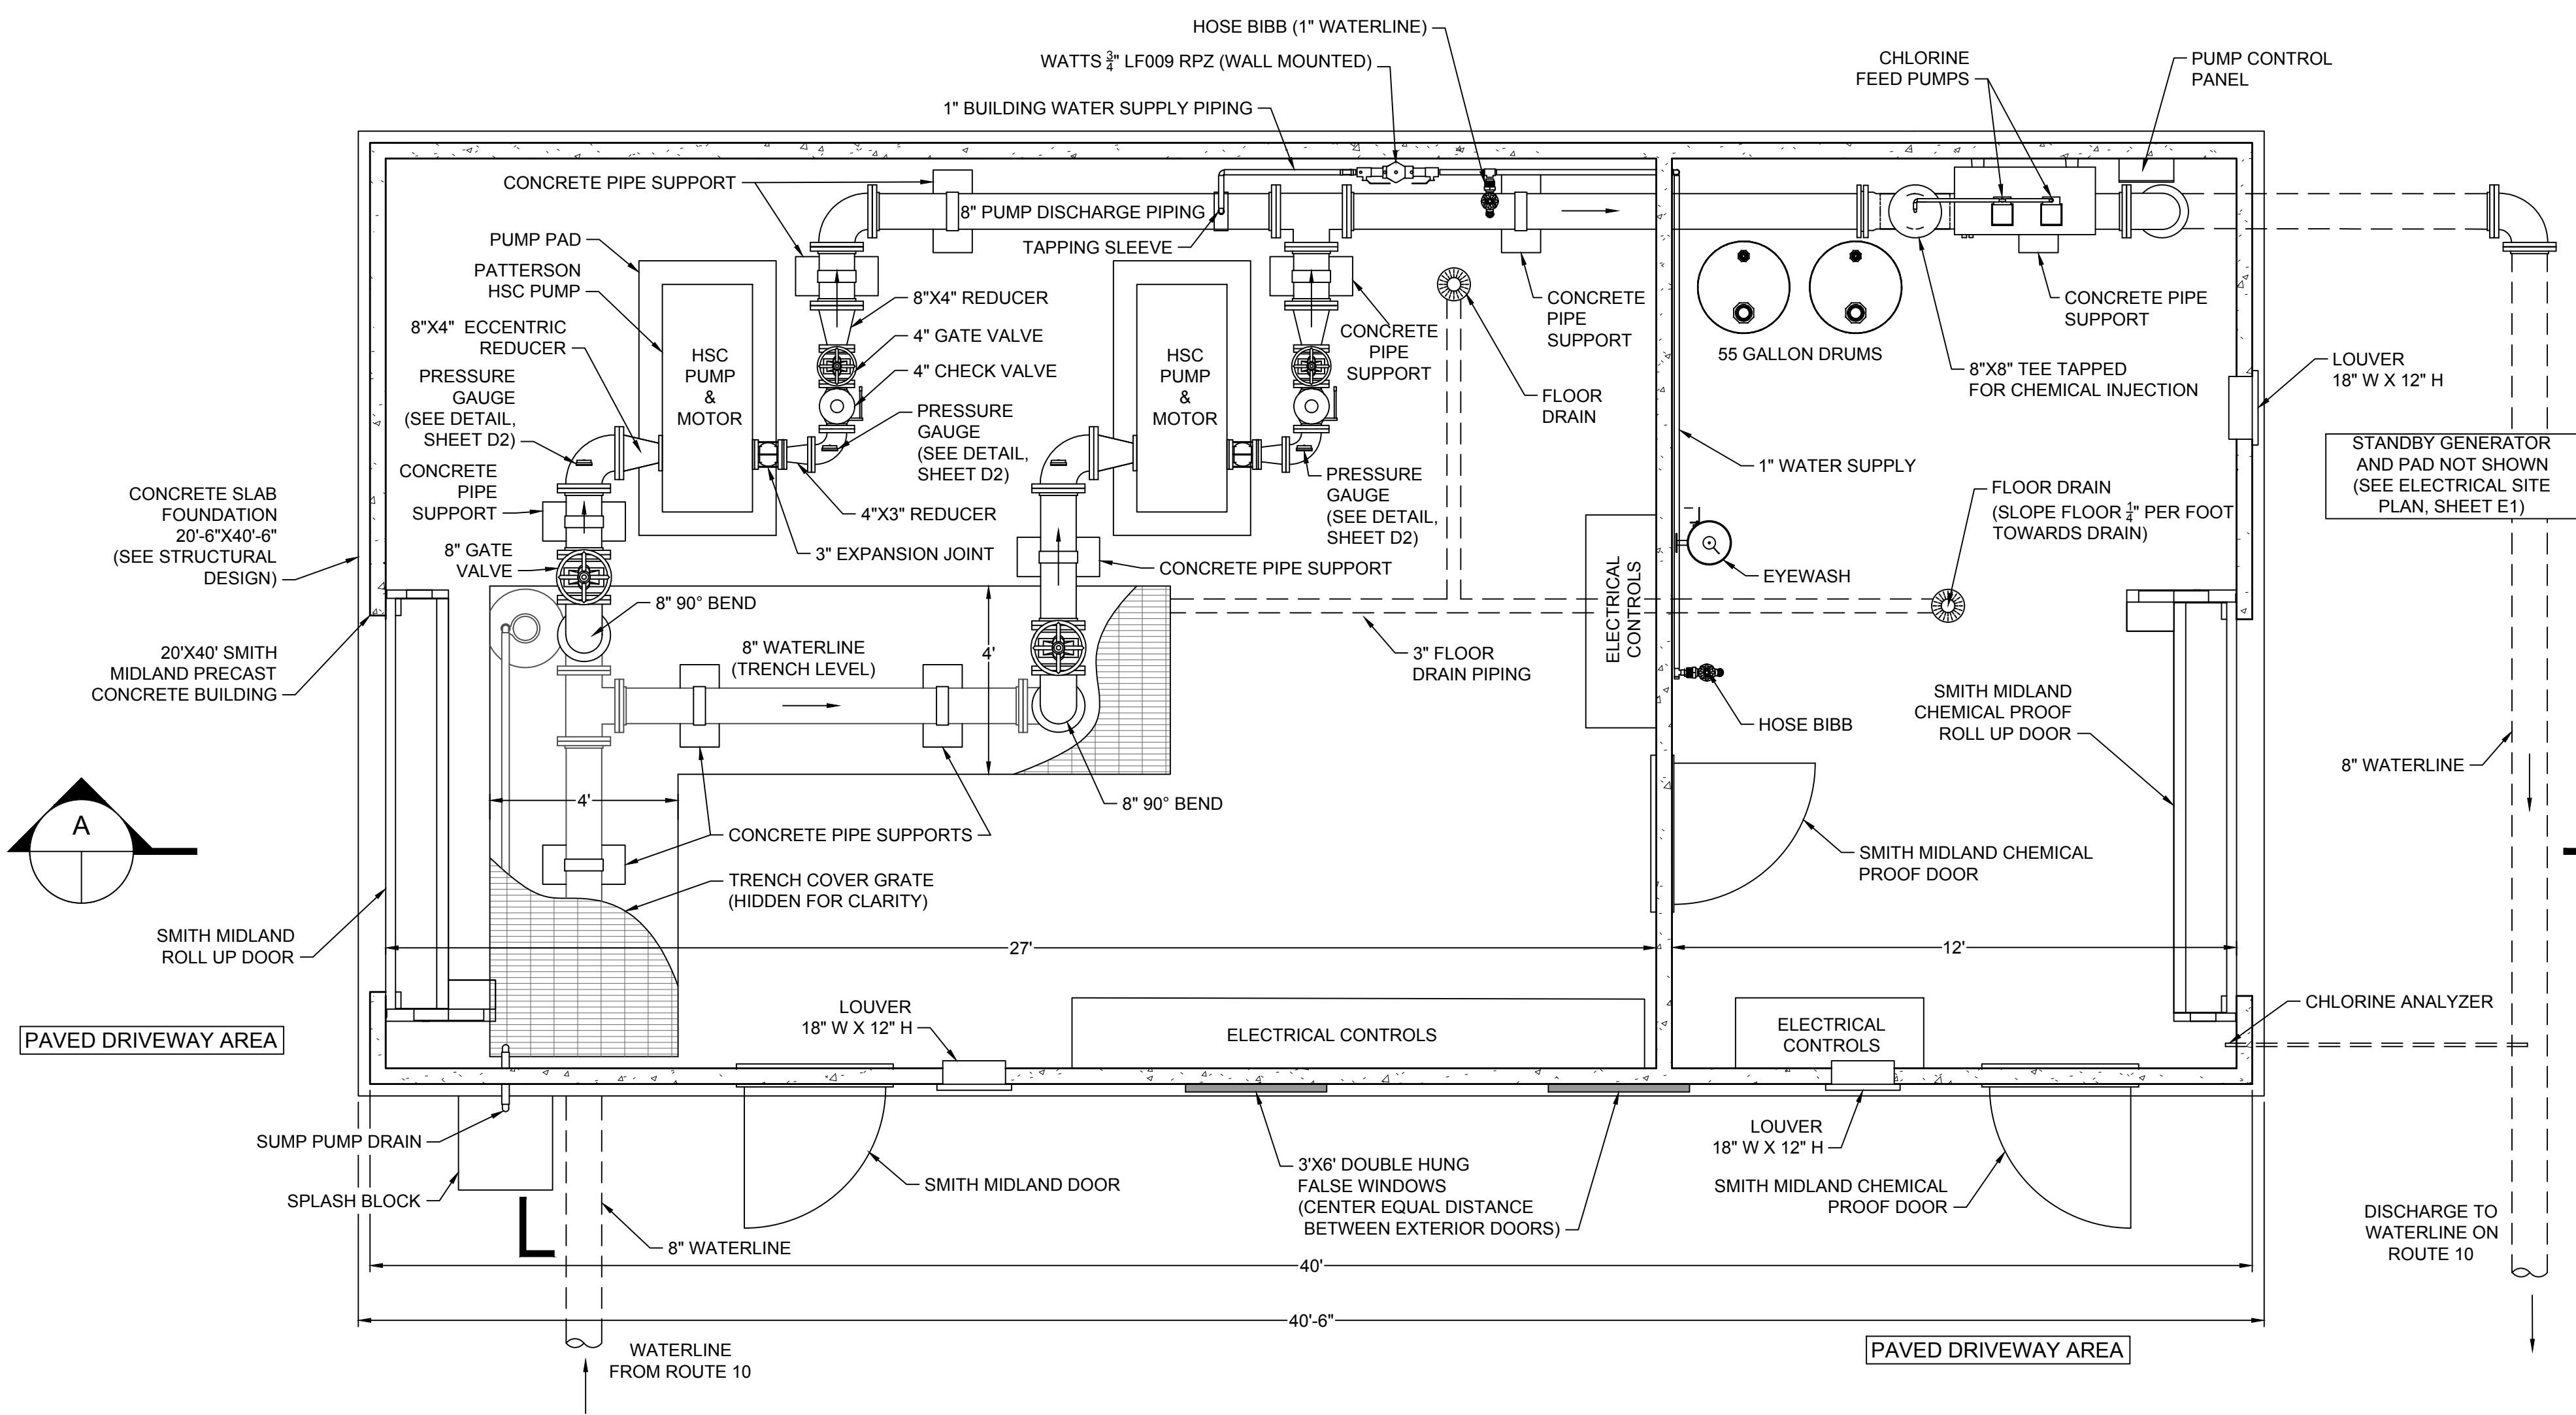

BOOSTER PUMP STATION FLOOR PLAN